

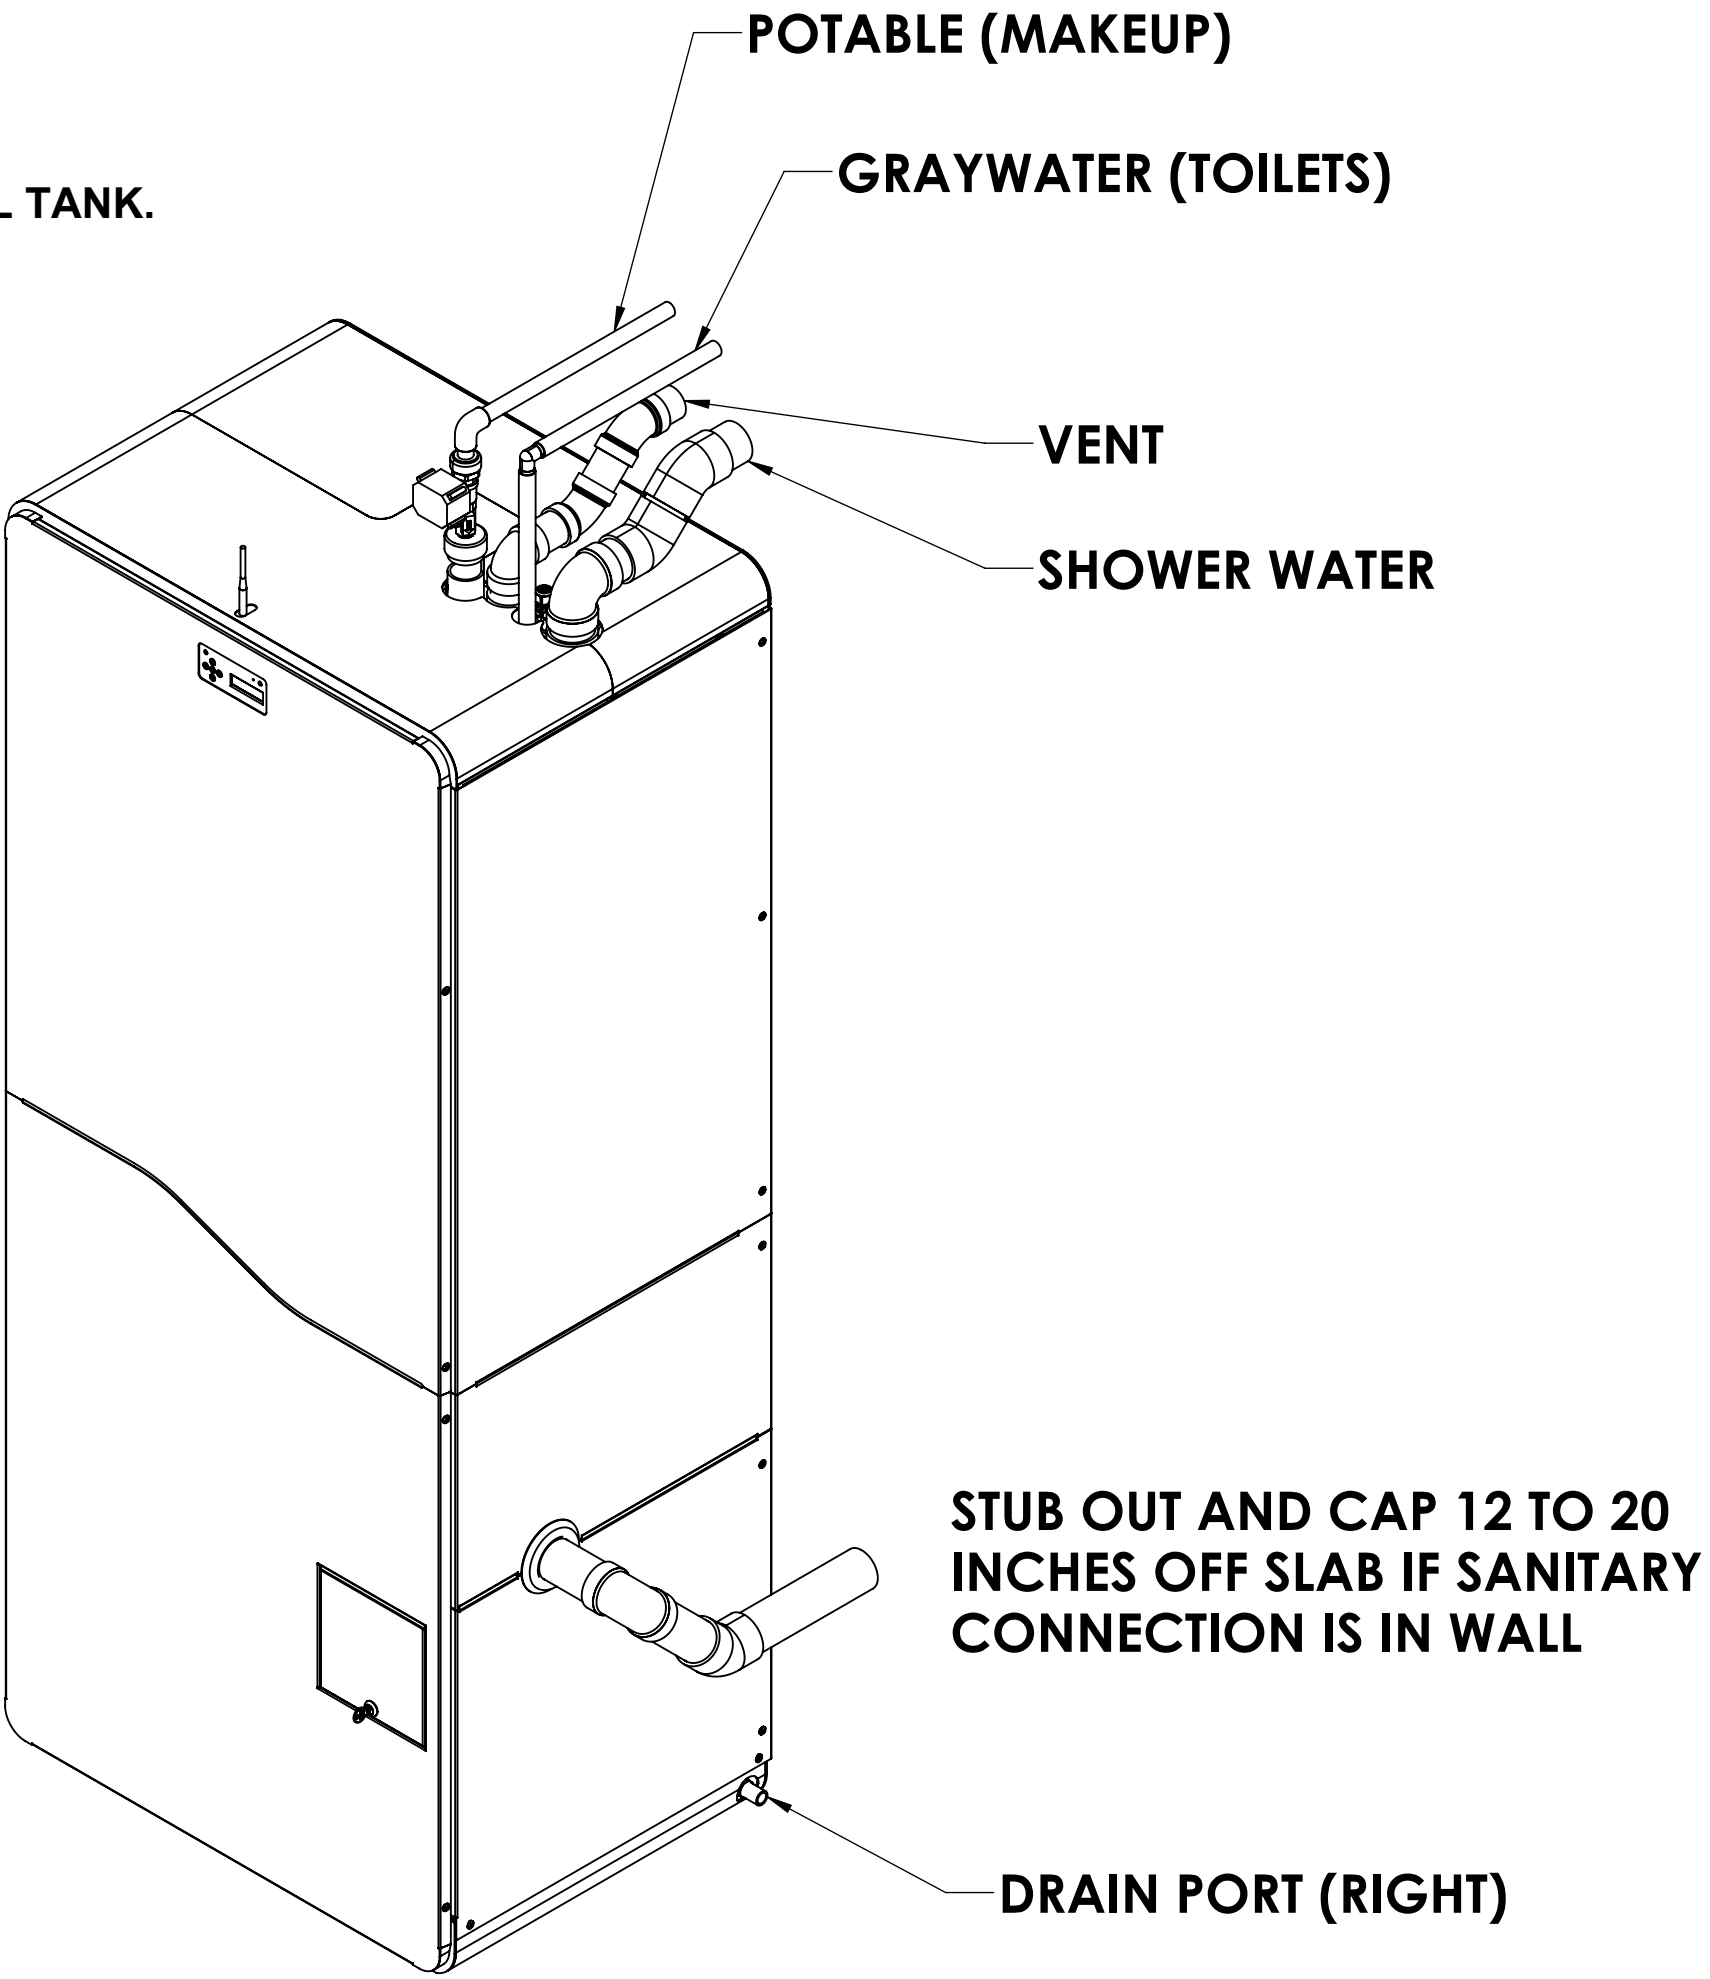
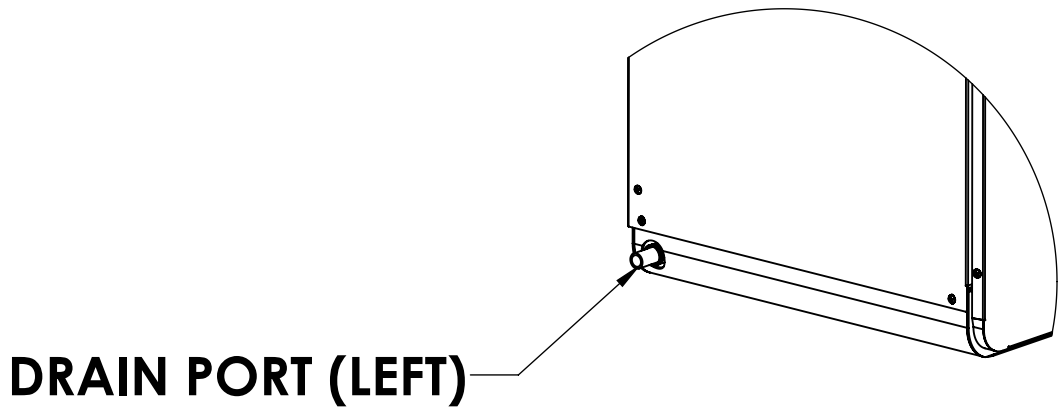


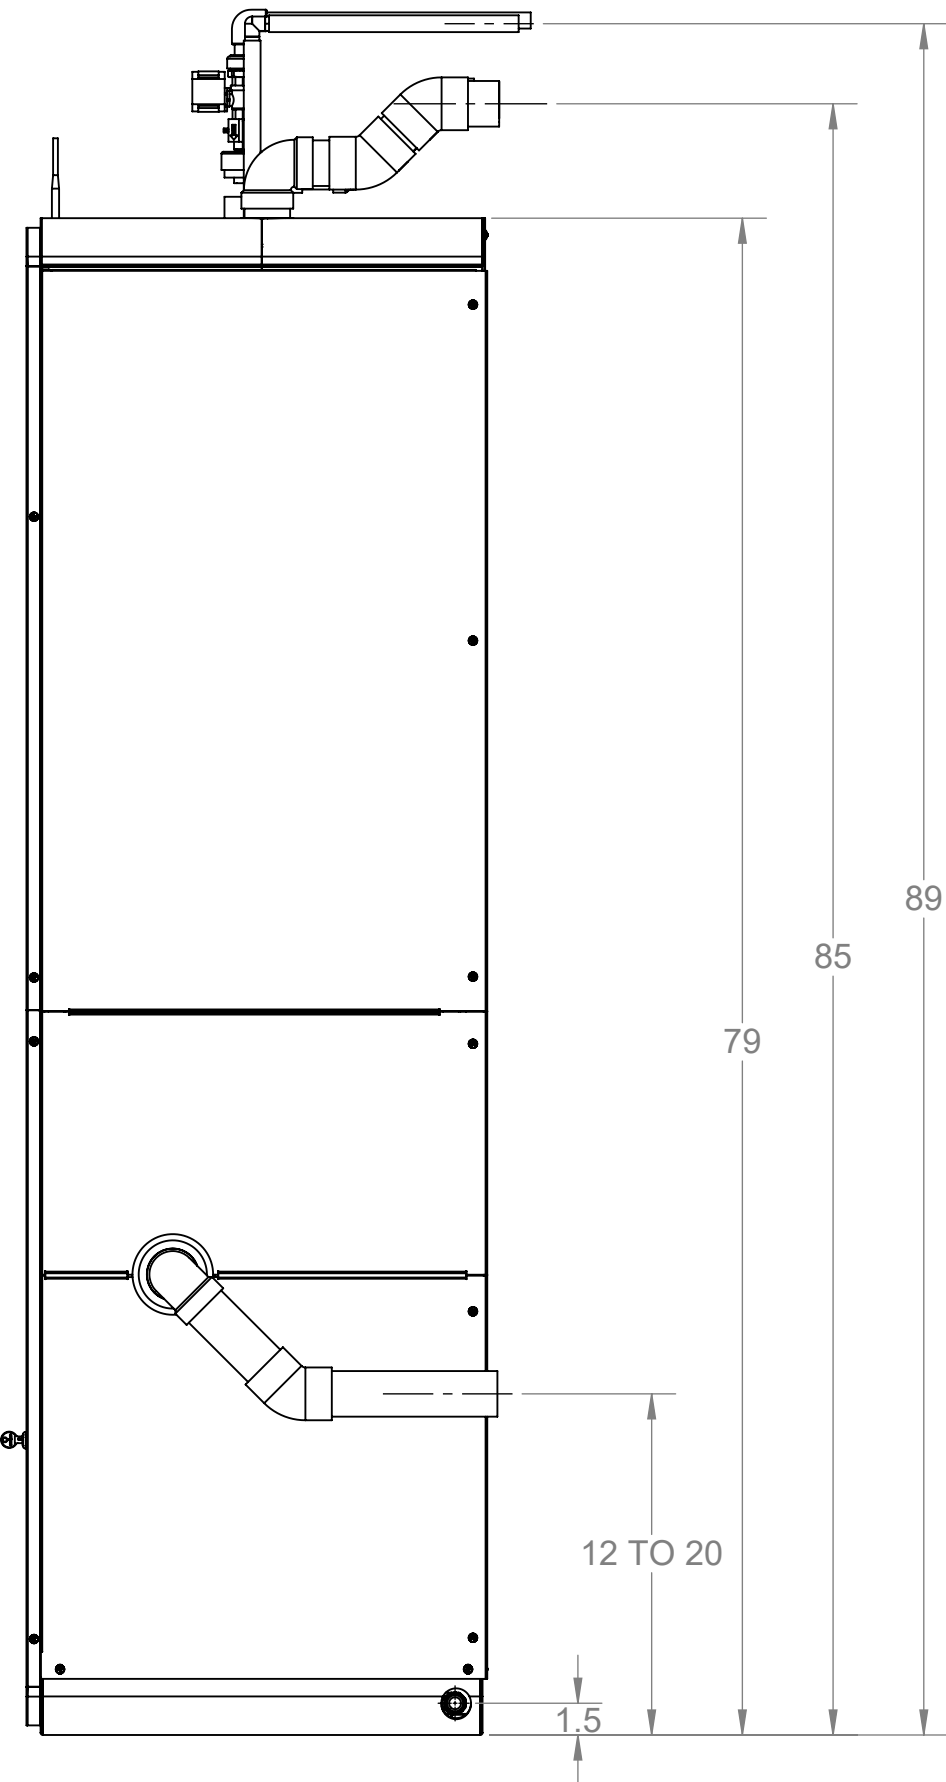

CONNECTIONS FOR FINISHED GARAGE OR MECHANICAL ROOM

1. ALL CONNECTIONS TO BE STUBBED OUT FROM WALL AT 90" OFF FLOOR
2. HAVE CONNECTIONS ON RIGHT QUADRANT OF SYSTEM FOR CLEANER INSTALL
3. STUB OUT IN THIS ORDER
  - WATER LINES FIRST
    1. POTABLE
    2. GRAYWATERTHESE WILL BE LOOPED UNTIL INSTALLATION  
GRAYWATER FEED MUST BE PURPLE PIPE
  - 3. VENT
  - 4. SHOWER WATER
4. IF UNFINISHED BASEMENT AND NO DRYWALL, IT DOES NOT NEED TO BE AS PRECISE
5. THE GREYTER HOME REQUIRES 1/2" DRAIN CONNECTION (CPVC) FOR MECHANICAL TANK.
  - EITHER LEFT SIDE OR RIGHT SIDE
  - DRAIN PLUG PROVIDED FOR SIDE NOT BEING CONNECTED
  - CONNECTION MUST GO TO AN INTERNAL FLOOR DRAIN OR TO EXTERIOR

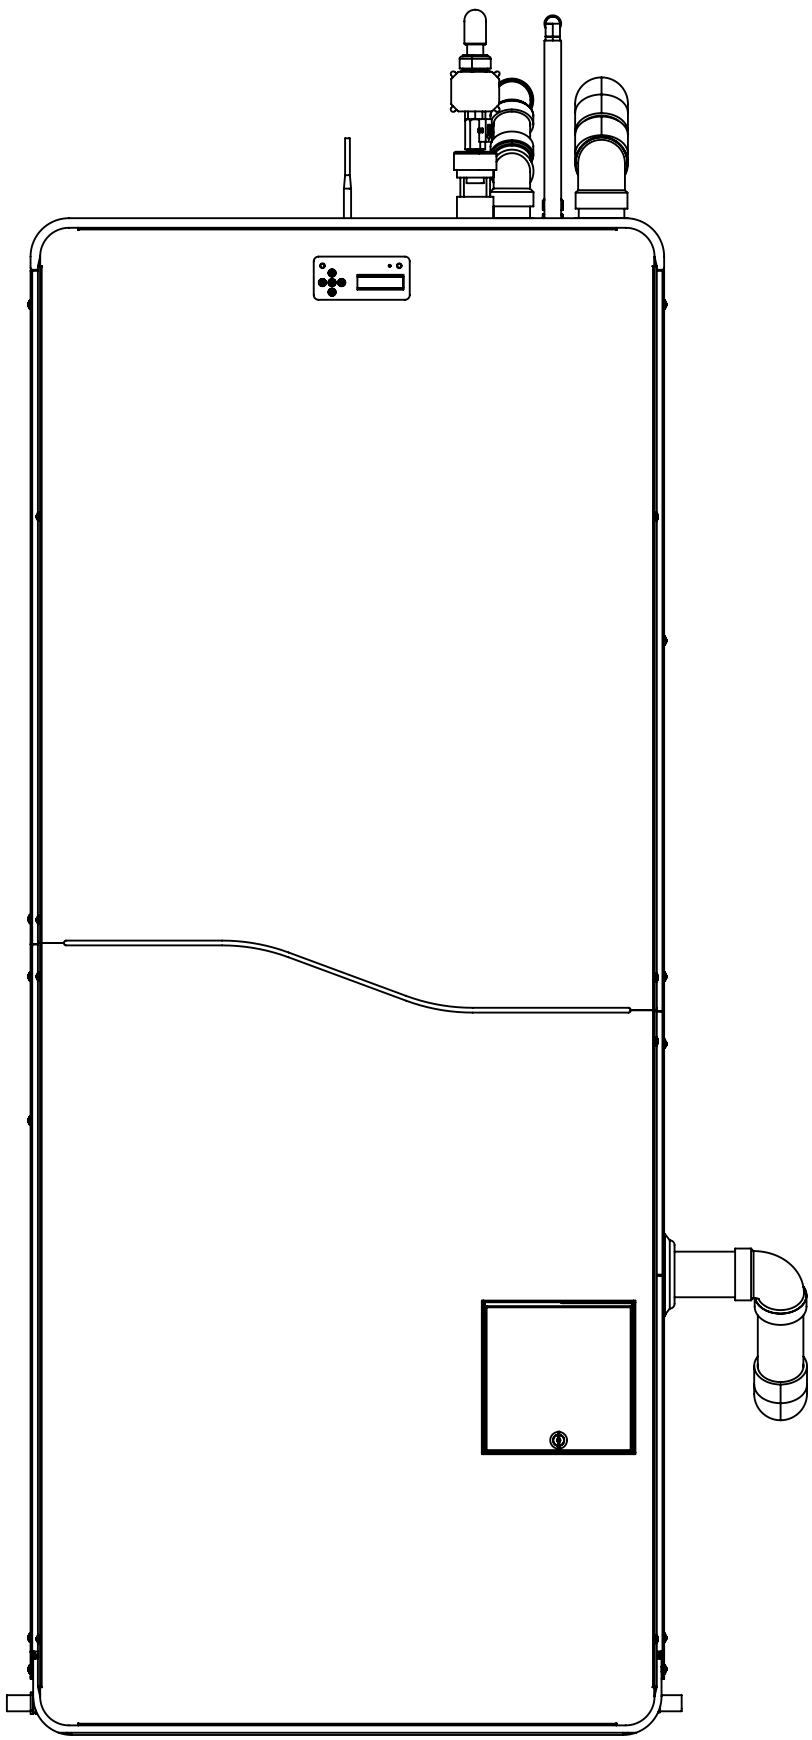

IF CONNECTING TO SANITARY STACK IN THE SLAB, MAKE SURE STACK IS MINIMUM OF 6 INCHES OFF GREYTER UNIT



UNLESS OTHERWISE SPECIFIED:  DIMENSIONS ARE IN INCHES TOLERANCES: FRACTIONAL ±.06 ANGULAR ±1 TWO PLACE DECIMAL ±.02 THREE PLACE DECIMAL ±.010		APPROVALS		DATE	<div></div>	TITLE:	
MATERIAL		DRAWN	TK	2024-07-30			
		CHECKED	T.KING	2024-07-31			
		ENG	TOM	2024-08-01			
		MFG	TLK	2024-08-02			
FINISH		THIRD ANGLE PROJECTION		SIZE DWG. NO.		REV	
<div></div> <b>PROPRIETARY AND CONFIDENTIAL</b> THE INFORMATION CONTAINED IN THIS DRAWING IS THE SOLE PROPERTY OF GREYTER WATER SYSTEM INC. ANY REPRODUCTION IN PART OR AS A WHOLE WITHOUT THE WRITTEN PERMISSION OF GREYTER WATER SYSTEM INC IS PROHIBITED.		<b>D GEN 3 - B PIPING LAYOUT</b>				<b>01</b>	
		DO NOT SCALE DRAWING				SCALE: 1:10	SHEET 1 OF 1